



PLATE_102_PROFILE_20210701.dwg Jul 19, 2021-7:39am

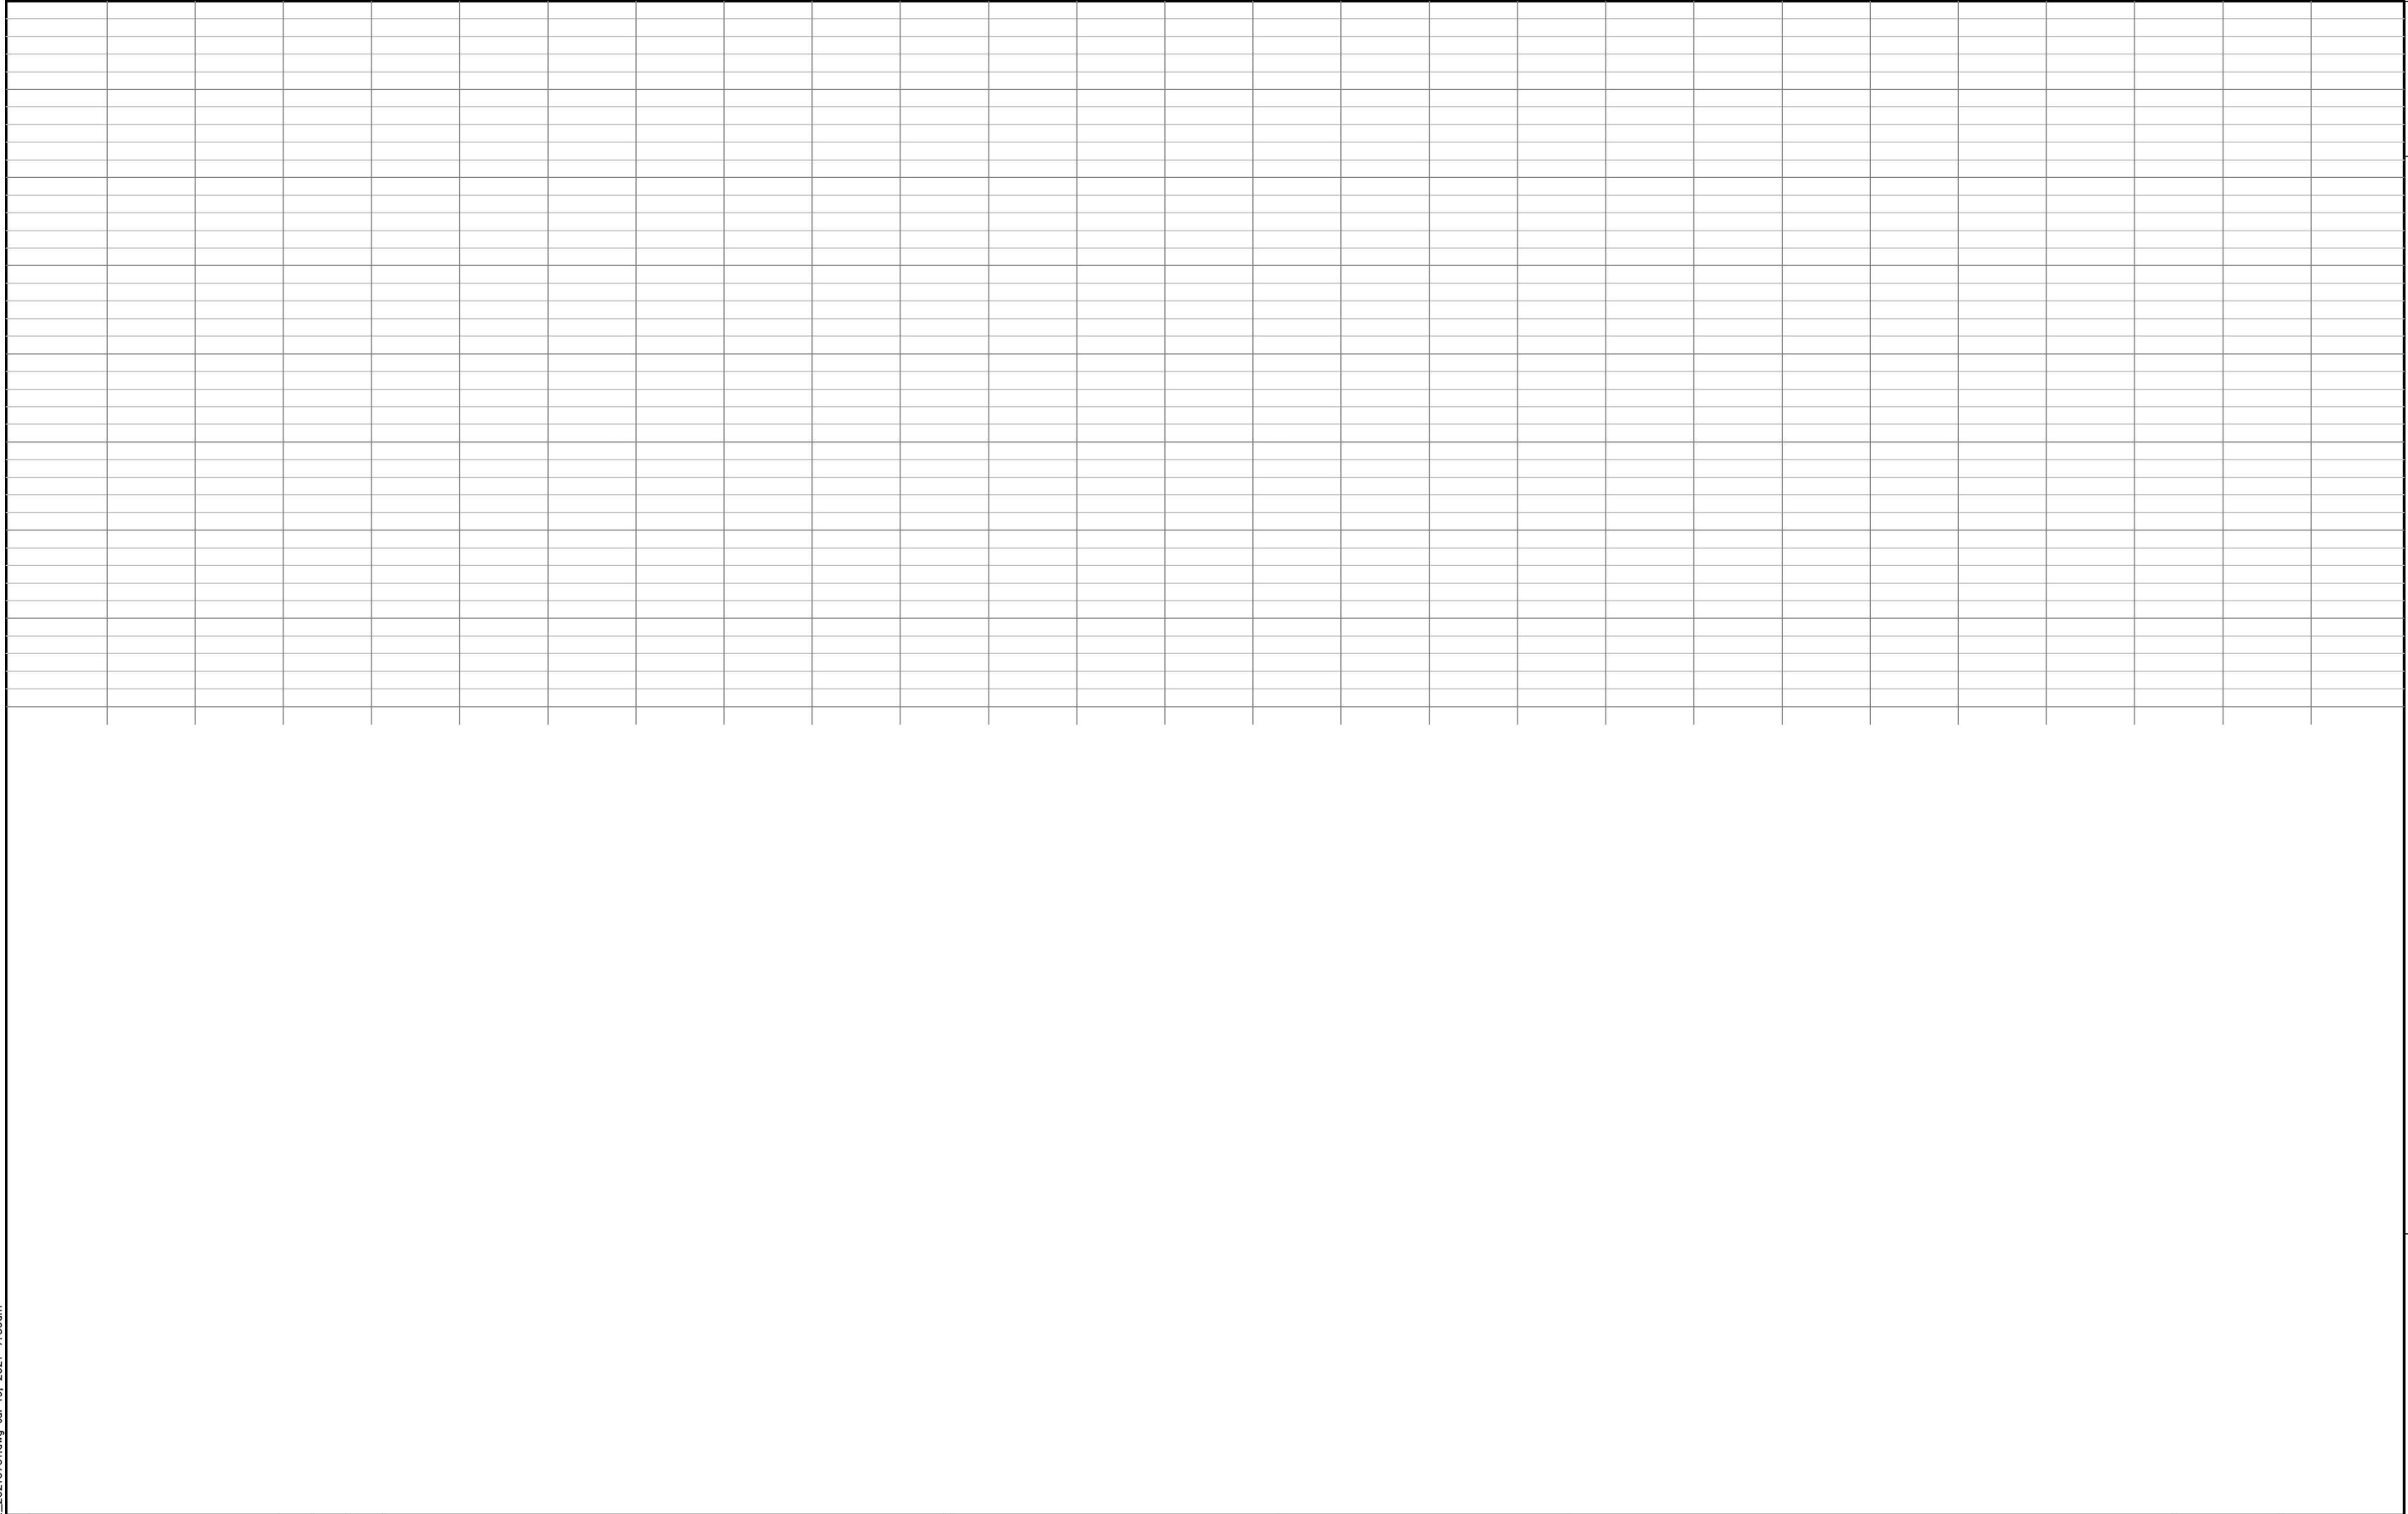

NO.	REVISION	PREP.	APPVD.	DATE

CITY OF SIMI VALLEY – VENTURA COUNTY WATERWORKS DISTRICT NO 8

REVIEWED: SENIOR ENGINEER _____ DATE _____

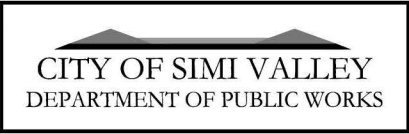

DESIGNED BY: DESBY
DRAWN BY: DRNBY
DATE: _____ DATE _____

VENTURA COUNTY WATERWORKS DISTRICT NO.8

SHEET
PROJECT1
PROJECT2
PROJECT3
SVNUM

WATER PLAN SET
DRAWING NUMBER

2W OF TW
SHEET NUMBER

2 OF T
DWG

**Ventura County
Waterworks
District No. 8**



STANDARD PLAN AND PROFILE SHEET

RECOMMENDED: /S/
DEPUTY DIRECTOR / DISTRICT ENGINEER

APPROVED: /S/
DIRECTOR OF PUBLIC WORKS

JUL 2021

PLATE
102